


S.E. 1/4, SECTION 35, TOWNSHIP 28 N, RANGE 4 E, W.M.

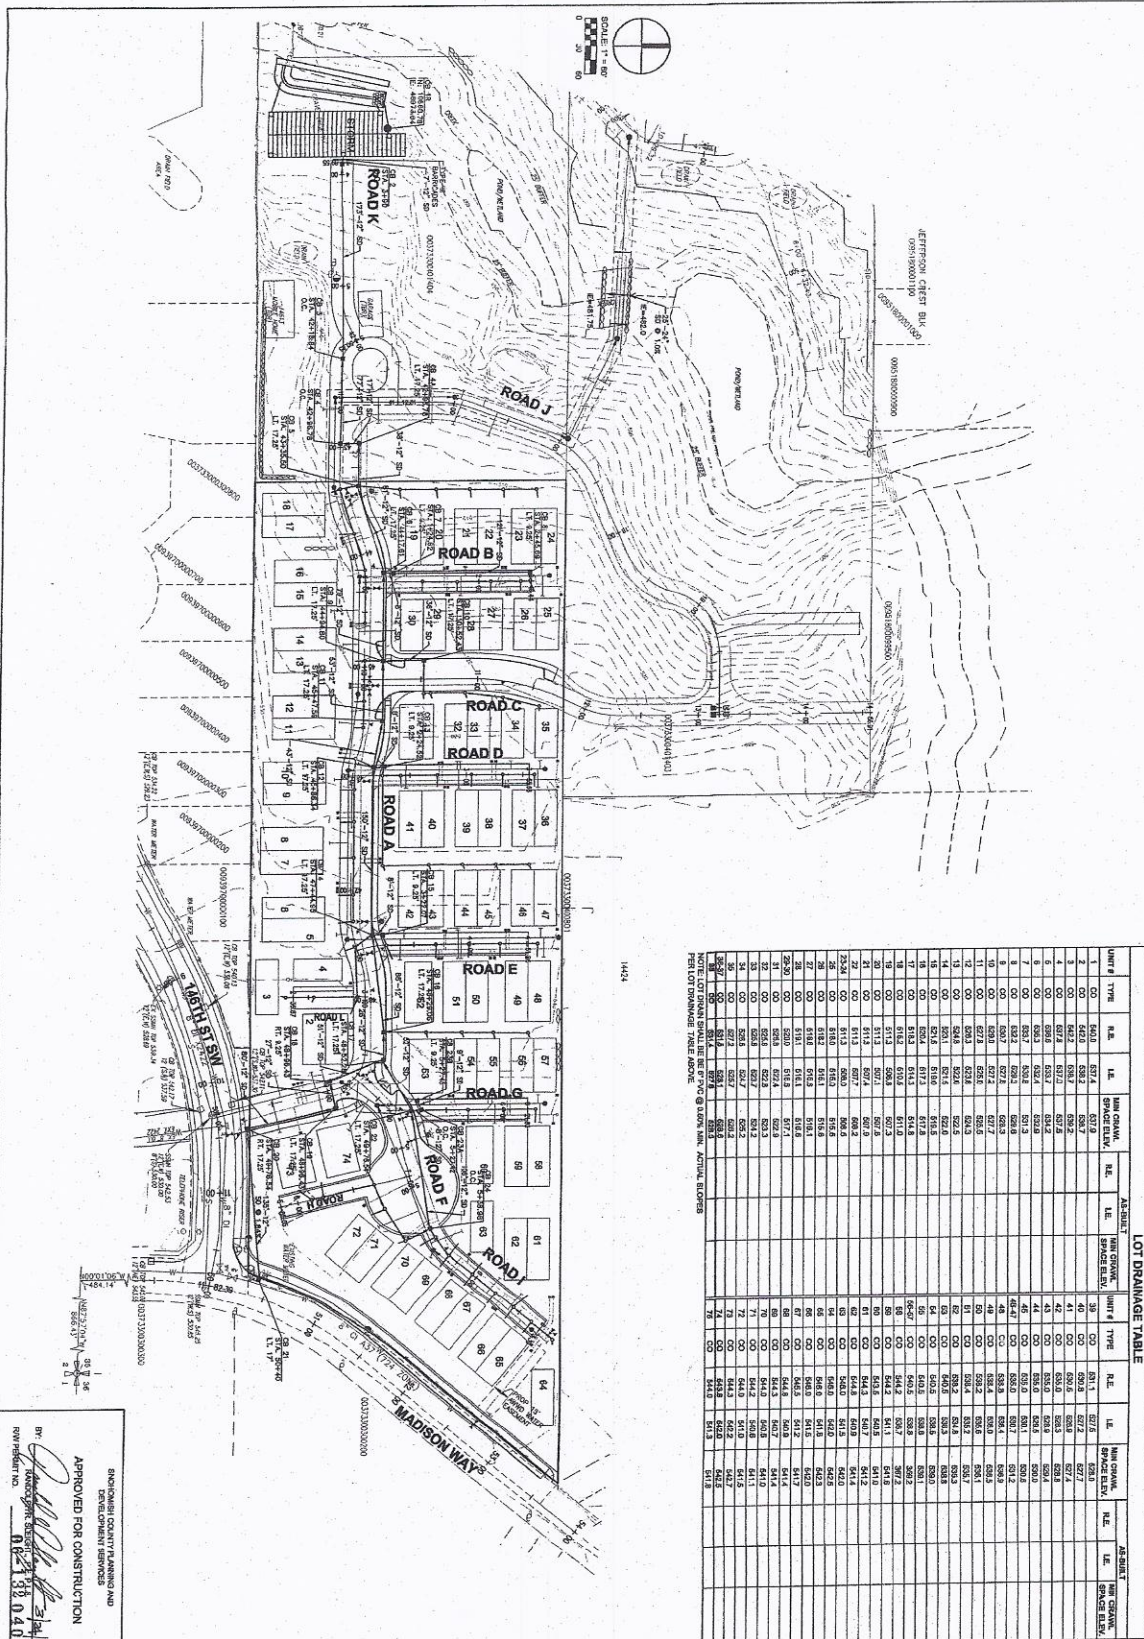


LOT DRAINAGE TABLE

UNIT #	TYPE	R.L.	I.E.	MIN. DRAIN. GRADE/FEET	R.L.	AS-BUILT		AS-BUILT	
						MIN. DRAIN. GRADE/FEET	R.L.	MIN. DRAIN. GRADE/FEET	R.L.
1	CO	524.3	527.4	527.9	528.7				
2	CO	524.3	528.3	528.7	529.7				
3	CO	524.3	529.3	529.7	530.7				
4	CO	527.2	527.2	527.2	527.2	38	CO	529.1	527.6
5	CO	528.4	528.7	528.7	528.7	40	CO	529.3	527.7
6	CO	528.4	528.7	528.7	528.7	42	CO	529.3	527.7
7	CO	528.4	528.7	528.7	528.7	44	CO	529.3	527.7
8	CO	528.4	528.7	528.7	528.7	46	CO	529.3	527.7
9	CO	528.4	528.7	528.7	528.7	48	CO	529.3	527.7
10	CO	528.4	528.7	528.7	528.7	50	CO	529.3	527.7
11	CO	528.4	528.7	528.7	528.7	52	CO	529.3	527.7
12	CO	528.4	528.7	528.7	528.7	54	CO	529.3	527.7
13	CO	528.4	528.7	528.7	528.7	56	CO	529.3	527.7
14	CO	528.4	528.7	528.7	528.7	58	CO	529.3	527.7
15	CO	528.4	528.7	528.7	528.7	60	CO	529.3	527.7
16	CO	528.4	528.7	528.7	528.7	62	CO	529.3	527.7
17	CO	528.4	528.7	528.7	528.7	64	CO	529.3	527.7
18	CO	528.4	528.7	528.7	528.7	66	CO	529.3	527.7
19	CO	528.4	528.7	528.7	528.7	68	CO	529.3	527.7
20	CO	528.4	528.7	528.7	528.7	70	CO	529.3	527.7
21	CO	528.4	528.7	528.7	528.7	72	CO	529.3	527.7
22	CO	528.4	528.7	528.7	528.7	74	CO	529.3	527.7
23	CO	528.4	528.7	528.7	528.7	76	CO	529.3	527.7
24	CO	528.4	528.7	528.7	528.7	78	CO	529.3	527.7
25	CO	528.4	528.7	528.7	528.7	80	CO	529.3	527.7
26	CO	528.4	528.7	528.7	528.7	82	CO	529.3	527.7
27	CO	528.4	528.7	528.7	528.7	84	CO	529.3	527.7
28	CO	528.4	528.7	528.7	528.7	86	CO	529.3	527.7
29	CO	528.4	528.7	528.7	528.7	88	CO	529.3	527.7
30	CO	528.4	528.7	528.7	528.7	90	CO	529.3	527.7
31	CO	528.4	528.7	528.7	528.7	92	CO	529.3	527.7
32	CO	528.4	528.7	528.7	528.7	94	CO	529.3	527.7
33	CO	528.4	528.7	528.7	528.7	96	CO	529.3	527.7
34	CO	528.4	528.7	528.7	528.7	98	CO	529.3	527.7
35	CO	528.4	528.7	528.7	528.7	100	CO	529.3	527.7

144.4  
 PLOT/DRAINAGE TABLE ABOVE  
 @ 1/8" = 1' SCALE. ACTUAL ELEVATIONS.

ENGINEER CONSULTING AND ENVIRONMENTAL SERVICES  
 APPROVED FOR CONSTRUCTION  
 DATE: 08/11/09  
 SHEET NO. 110.040

**GREENBROOK  
 PHASE II**  
 DRAINAGE & UTILITY PLAN  
 PFN: 05-129152 LU

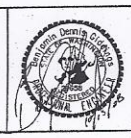

DATE	REVISION	BY
9/20/09	LAYOUT CHANGE TO ATTACHED UNITS	KDL

Dec 15, 2008 - 7:44am ktds J:\PROJECTS\Greenbrook\CONSTRUCTION\1308-Civil\Drawings\NEW\DWG Layout Name: PG0